



© Crown copyright and database rights 2014. Ordnance Survey licence number 100047514
Notes:
 This drawing is to be used in conjunction with all relevant drawings and specifications.
 Do not scale from this drawing, the layout dimensions only. All levels and dimensions to be checked on site. All levels and dimensions in brackets are to be taken to the immediate attention of HSSP Architects Ltd.
 Responsibility cannot be accepted for alterations made to this drawing without the written consent of HSSP Architects Ltd.
 Copyright reserved. This drawing may only be used for the client and location specified in the title block. It may not be copied or distributed to other parties without the written consent of HSSP Architects Ltd.
 This drawing is the property of HSSP Architects Ltd. It is to be returned to the architect upon completion of the project.
 All work to be to the satisfaction of the HSE or local Authority with all relevant drawings drawn or submitted on these drawings. All work to be completed to the satisfaction of the HSE and local Authority.
 The drawing is to be read in conjunction with the relevant specifications, standards and codes of practice.
 The drawing is to be read in conjunction with the relevant specifications, standards and codes of practice.
 The drawing is to be read in conjunction with the relevant specifications, standards and codes of practice.

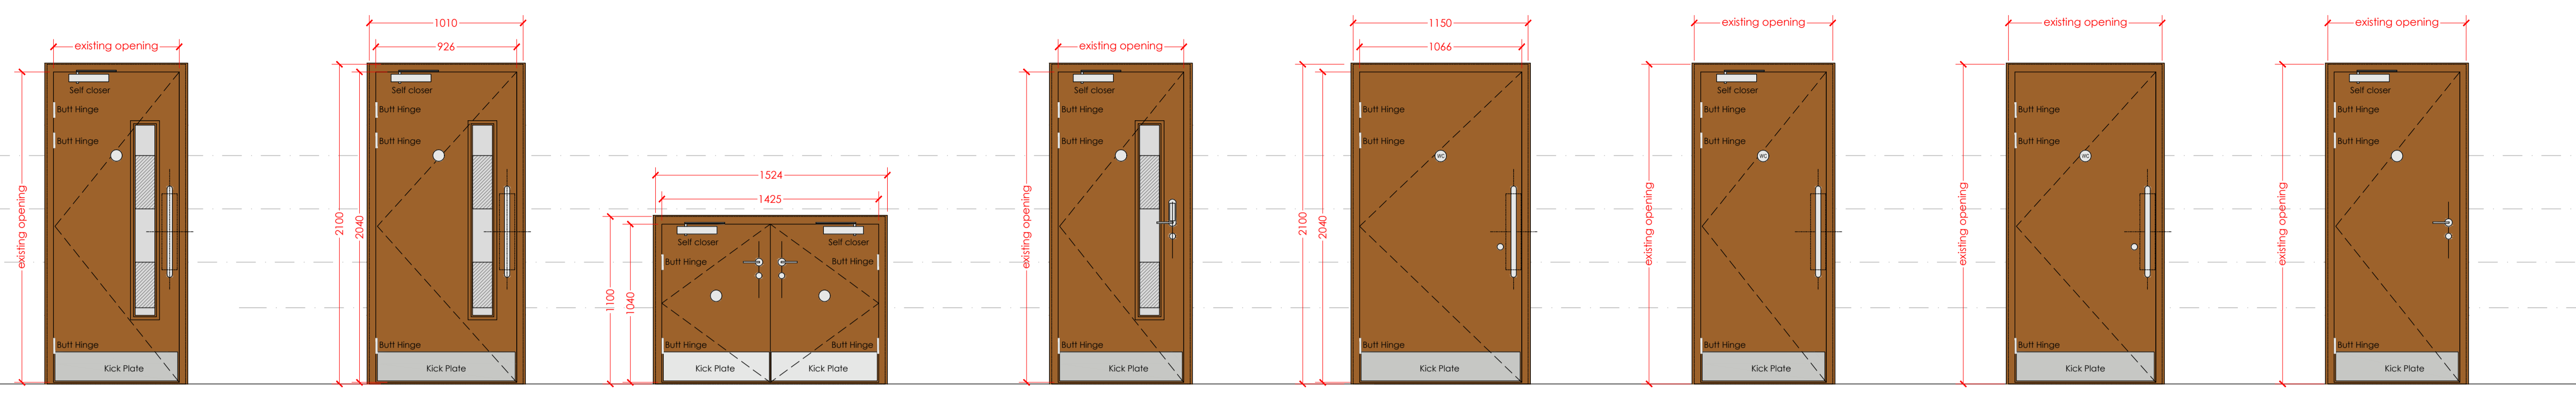

<p>TYPE 01 Internal</p> <p>Material Veneered 44mm thick solidcore</p> <p>Glazing 60 min fire protected glass</p> <p>Hung Site Specific</p> <p>Opening As existing x As existing</p> <p>Location Corridor - 00-ld-01</p> <p>Fire Rating 60 minutes</p> <p>Locking N / A</p> <p>Other Self closing device, smoke seals, intumescent strips, vision panel, kick plates both sides, pull handle, push plate, fire signage, door stop. NOTE: To be read in conjunction with Finishes Schedule.</p>	<p>TYPE 02 Internal - omitted</p> <p>00-ld-02 now type 14 door</p>	<p>TYPE 03 Internal</p> <p>Material Veneered 44mm thick solidcore</p> <p>Glazing N/A</p> <p>Hung Site Specific</p> <p>Opening 1524 x 1100mm</p> <p>Location Under stage storage - 00-ld-03 & 00-ld-04</p> <p>Fire Rating 30 minutes</p> <p>Locking Mortice lock 5 lever pack and Euro profile escutcheon.</p> <p>Other Self closing device, smoke seals, intumescent strips, vision panel, kick plates both sides, lever handles, door stop. NOTE: To be read in conjunction with Finishes Schedule.</p>	<p>TYPE 04 Internal</p> <p>Material Veneered 44mm thick solidcore</p> <p>Glazing N/A</p> <p>Hung Site Specific</p> <p>Opening As existing x As existing</p> <p>Location Corridor - 00-ld-05</p> <p>Fire Rating 60 minutes</p> <p>Locking Digital lock to opening leaf operated from hall side. To be interlinked with fire alarm.</p> <p>Other Self closing device, smoke seals, intumescent strips, vision panel, kick plates both sides, lever handle, fire signage, door stop. NOTE: To be read in conjunction with Finishes Schedule.</p>	<p>TYPE 05 Internal</p> <p>Material Veneered 44mm thick solidcore</p> <p>Glazing N / A</p> <p>Hung Site Specific</p> <p>Opening 1150 x 2100mm</p> <p>Location Changing places WC - 00-ld-06</p> <p>Fire Rating 30 minutes</p> <p>Locking By specialist - Part M, BS8300, The Equality Act 2010 compliant. Mortice lock 5 lever pack and Euro profile escutcheon - accessed with RADAR key (see RADAR National Key Scheme).</p> <p>Other Kick plate both sides, pull handle, push plate, WC signage compliant inclusive label lever handle, lock and indicator bolt, grab rail, door stop. NOTE: To be read in conjunction with Finishes Schedule.</p>	<p>TYPE 06 Internal</p> <p>Material Veneered 44mm thick solidcore</p> <p>Glazing N / A</p> <p>Hung Site Specific</p> <p>Opening As existing x As existing</p> <p>Location Female WC (1) - 00-ld-07</p> <p>Fire Rating 30 minutes</p> <p>Locking N / A</p> <p>Other Self closing device, smoke seals, intumescent strips, kick plate both sides, pull handle, push plate, WC signage, fire signage, door stop. NOTE: To be read in conjunction with Finishes Schedule.</p>	<p>TYPE 07 Internal</p> <p>Material Veneered 44mm thick solidcore</p> <p>Glazing N / A</p> <p>Hung Site Specific</p> <p>Opening As existing x As existing</p> <p>Location Disabled WC - 00-ld-08</p> <p>Fire Rating 30 minutes</p> <p>Locking By specialist - Part M, BS8300, The Equality Act 2010 compliant.</p> <p>Other Kick plate both sides, pull handle, push plate, WC signage, compliant inclusive label lever handle, lock and indicator bolt, grab rail, door stop. NOTE: To be read in conjunction with Finishes Schedule.</p>	<p>TYPE 08 Internal</p> <p>Material Veneered 44mm thick solidcore</p> <p>Glazing N/A</p> <p>Hung Site Specific</p> <p>Opening As existing x As existing</p> <p>Location Cubboard - 00-ld-09</p> <p>Fire Rating 30 minutes</p> <p>Locking Mortice lock 5 lever pack and Euro profile escutcheon.</p> <p>Other Self closing device, smoke seals, intumescent strips, kick plate both sides, lever handles, fire signage, door stop. To be read in conjunction with Finishes Schedule.</p>
---	---	--	---	---	---	--	---

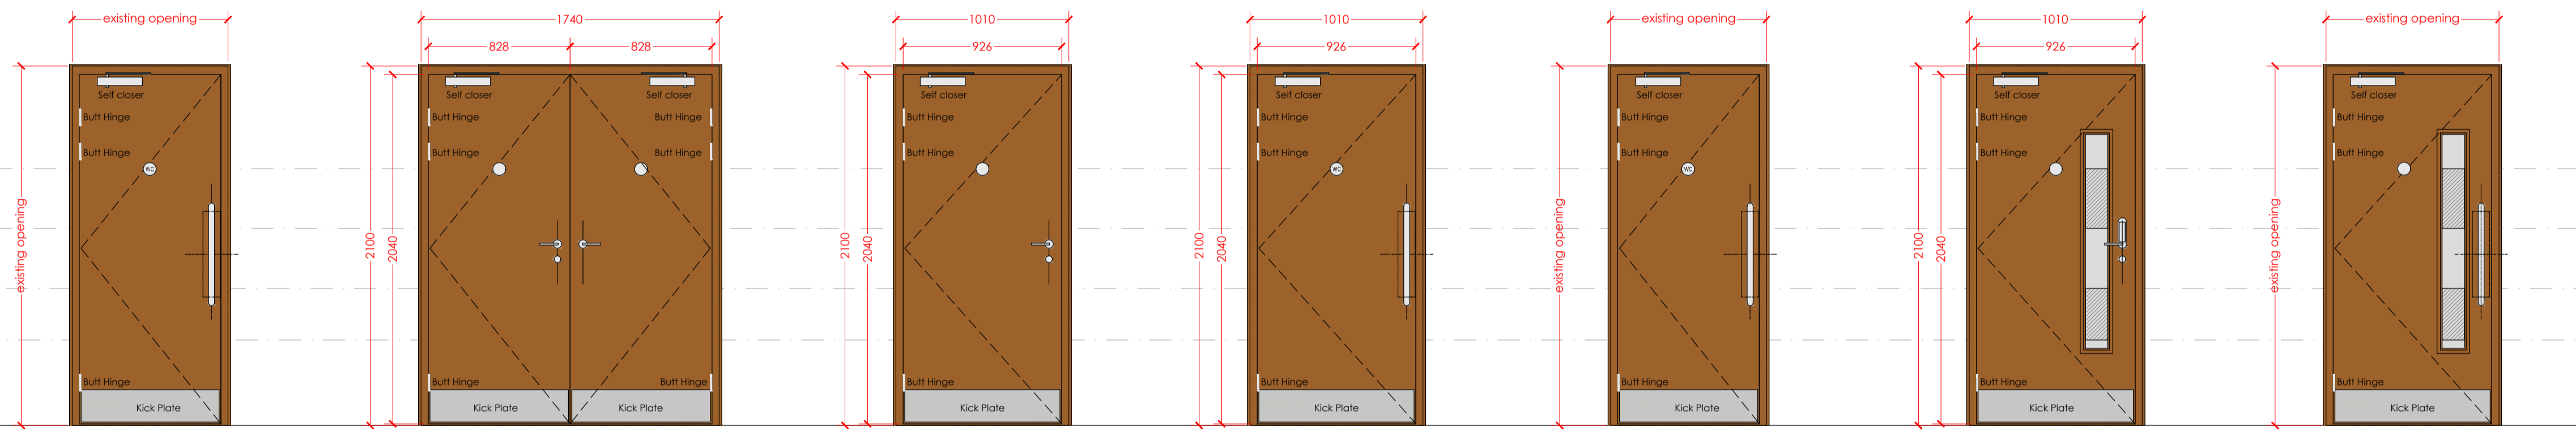

<p>TYPE 09 Internal</p> <p>Material Veneered 44mm thick solidcore</p> <p>Glazing N / A</p> <p>Hung Site Specific</p> <p>Opening As existing x As existing</p> <p>Location Male WC - 00-ld-10</p> <p>Fire Rating 30 minutes</p> <p>Locking N / A</p> <p>Other Self closing device, smoke seals, intumescent strips, kick plate both sides, pull handle, push plate, WC signage, fire signage, door stop. NOTE: To be read in conjunction with Finishes Schedule.</p>	<p>TYPE 10 Internal</p> <p>Material Veneered 54mm thick solidcore</p> <p>Glazing N / A</p> <p>Hung Site Specific</p> <p>Opening 1740 x 2100mm</p> <p>Location Storage - 00-ld-11</p> <p>Fire Rating 30 minutes</p> <p>Locking Mortice lock 5 lever pack and Euro profile escutcheon.</p> <p>Other Self closing device, smoke seals, intumescent strips, fire signage, kick plate both sides, lever handles, door stop. NOTE: To be read in conjunction with Finishes Schedule.</p>	<p>TYPE 11 Internal</p> <p>Material Veneered 44mm thick solidcore</p> <p>Glazing N/A</p> <p>Hung Site Specific</p> <p>Opening 1010 x 2100mm</p> <p>Location Cleaner store - 00-ld-12</p> <p>Fire Rating 30 minutes</p> <p>Locking Mortice lock 5 lever pack and Euro profile escutcheon.</p> <p>Other Self closing device, smoke seals, intumescent strips, kick plate both sides, pull handle, push plate, WC signage, fire signage, door stop. NOTE: To be read in conjunction with Finishes Schedule.</p>	<p>TYPE 12 Internal</p> <p>Material Veneered 44mm thick solidcore</p> <p>Glazing N / A</p> <p>Hung Site Specific</p> <p>Opening 1010 x 2100mm</p> <p>Location Male WC (2) - 00-ld-13</p> <p>Fire Rating 30 minutes</p> <p>Locking N / A</p> <p>Other Self closing device, smoke seals, intumescent strips, kick plate both sides, pull handle, push plate, WC signage, fire signage, door stop. NOTE: To be read in conjunction with Finishes Schedule.</p>	<p>TYPE 13 Internal</p> <p>Material Veneered 44mm thick solidcore</p> <p>Glazing N / A</p> <p>Hung Site Specific</p> <p>Opening As existing x As existing</p> <p>Location Female WC (2) - 00-ld-14</p> <p>Fire Rating 30 minutes</p> <p>Locking N / A</p> <p>Other Self closing device, smoke seals, intumescent strips, kick plate both sides, pull handle, push plate, WC signage, fire signage, door stop. NOTE: To be read in conjunction with Finishes Schedule.</p>	<p>TYPE 14 Internal</p> <p>Material Veneered 54mm thick solidcore</p> <p>Glazing 60 min fire protected glass</p> <p>Hung Site Specific</p> <p>Opening 1010 x 2100mm</p> <p>Location Kitchen - 00-ld-15 & canteen (staff kitchen) - 00-ld-02</p> <p>Fire Rating 60 minutes</p> <p>Locking Digital lock to opening leaf operated from corridor side. To be interlinked with fire alarm.</p> <p>Other Self closing device, smoke seals, intumescent strips, vision panel, fire signage, kick plate both sides, lever handle, fire signage, door stop. NOTE: To be read in conjunction with Finishes Schedule.</p>	<p>TYPE 15 Internal</p> <p>Material Veneered 54mm thick solidcore</p> <p>Glazing 60 min fire protected glass</p> <p>Hung Site Specific</p> <p>Opening As existing x As existing</p> <p>Location Corridor - 00-ld-16</p> <p>Fire Rating 60 minutes</p> <p>Locking N / A</p> <p>Other Self closing device, smoke seals, intumescent strips, vision panel, kick plates both sides, pull handle, push plate, fire signage, door stop. NOTE: To be read in conjunction with Finishes Schedule.</p>
---	--	--	---	---	---	---

 
WINDOW & DOOR SCHEDULE
Scale 1:25

INTERNAL DOORS:

- Premdor solid core ash veneered faced flush doors, hardwood lippings, MDF door frame and stop. Frame and stop finished with one coat primer, two coats undercoat and one coat high gloss white.

Please refer to door detail information and Travis Perkins finishes schedule for further information.

To be read in conjunction with the following drawings:
 7570_04_001 Proposed plan
 7570_04_002 Proposed sections
 7570_04_010 Proposed indicative electrical layout drawing
 and Proposed Finishes Schedule.



2021/11/02 - Rev. A: Type 2 door omitted, 00-ld-02 now a type 14 door, as per client request to include digital lock, Type 4 now to include digital lock.

Revision Status:

BUILDING REGS

hssp architects

Pera Business Park, Nottingham Road
 Melton Mowbray, LE13 0PB

Telephone: 01664 563 288 Fax: 01664 563 360
 E-Mail: info@hssparchitects.co.uk Web: www.hssparchitects.co.uk

Project:
 Proposed Internal Alterations
 Braunstone Civic Centre
 209 Kingsway, Braunstone
 for Braunstone Town Council

Title:
 Proposed door & window schedule - sheet 1

Scale:	1:25	Drawn:	KES	Checked:	-	Date:	April 2021
Drawing No.:	7570_04_011	Revision:	A				

HSSP A1